



**FRONT ELEVATION**

1/4" = 1'-0" ON 24" X 36" PAPER  
 1/8" = 1'-0" ON 11" X 17" PAPER



**LEFT ELEVATION**

1/4" = 1'-0" ON 24" X 36" PAPER  
 1/8" = 1'-0" ON 11" X 17" PAPER

SCALE: PER PLANS

PERSONAL HOME FOR  
 THE WESOLOWSKI FAMILY

0 MIDDLE STREET  
 SENOIA, GEORGIA

WESOLOWSKI  
 ELEVATIONS

REVISIONS	
•	DATE

DRAWN BY: R.C.  
 DATE: MARCH 2022


**KEYSTONE DESIGN ASSOCIATES, INC.**  
 27 LAKE FOREST DRIVE, NEWNAN, GA 30265

PROFESSIONAL MEMBER OF THE  
 AMERICAN INSTITUTE OF BUILDING DESIGN  
 CERTIFIED MEMBER OF THE NATIONAL COUNCIL  
 OF BUILDING DESIGNER CERTIFICATION



**REAR ELEVATION**

1/4" = 1'-0" ON 24" X 36" PAPER  
 1/8" = 1'-0" ON 11" X 17" PAPER

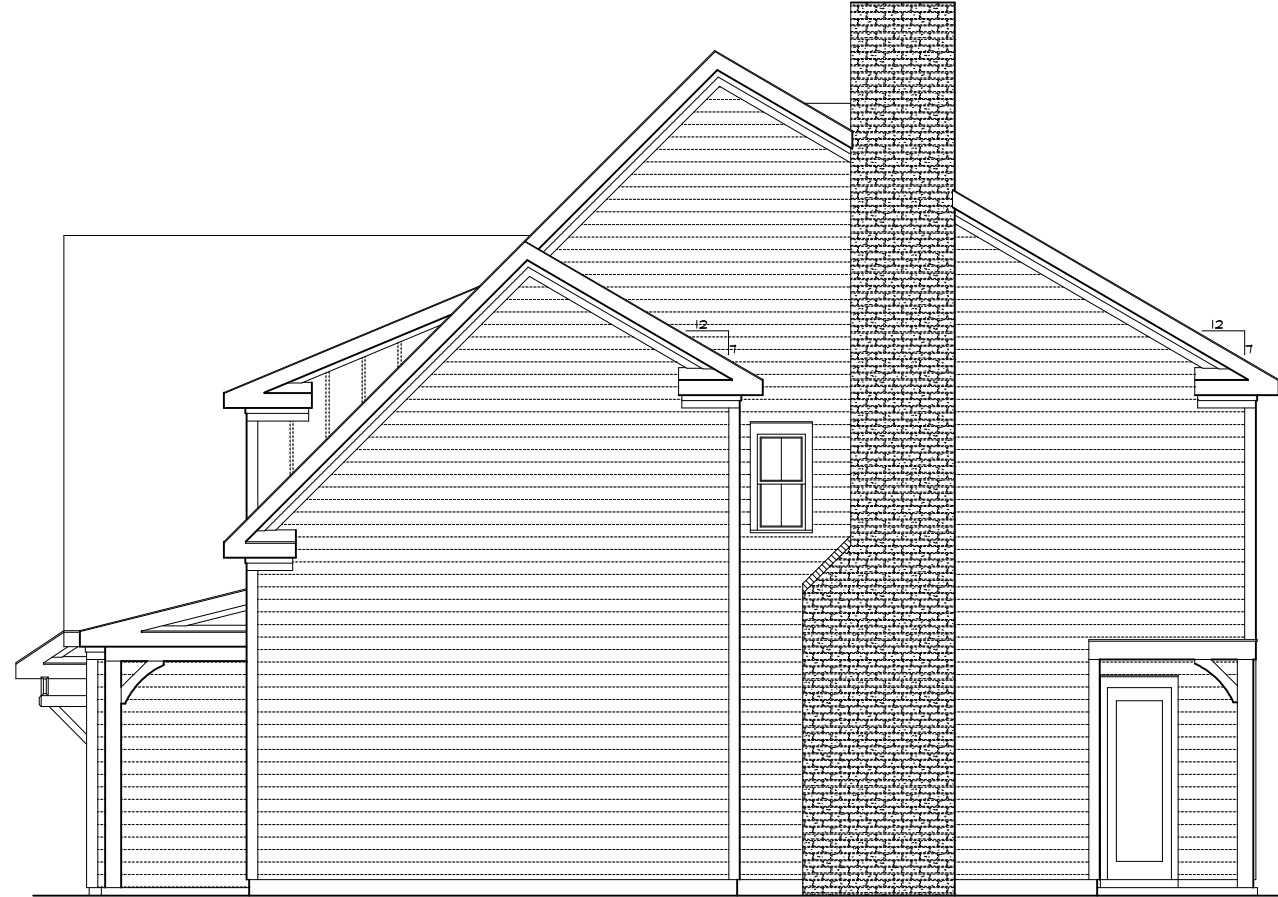

**RIGHT ELEVATION**

1/4" = 1'-0" ON 24" X 36" PAPER  
 1/8" = 1'-0" ON 11" X 17" PAPER

SCALE: PER PLANS

PERSONAL HOME FOR  
 THE WESOLOWSKI FAMILY

0 MIDDLE STREET  
 SENOIA, GEORGIA

WESOLOWSKI  
 ELEVATIONS

**REVISIONS**

NO.	DATE

**DRAWN BY: R.C.**

**DATE: MARCH 2022**

**KEYSTONE DESIGN ASSOCIATES, INC.**

**27 LAKE FOREST DRIVE, NEWNAN, GA 30265**

PROFESSIONAL MEMBER OF THE  
 AMERICAN INSTITUTE OF BUILDING DESIGN

01

01

01

01

01


01

01

01


01



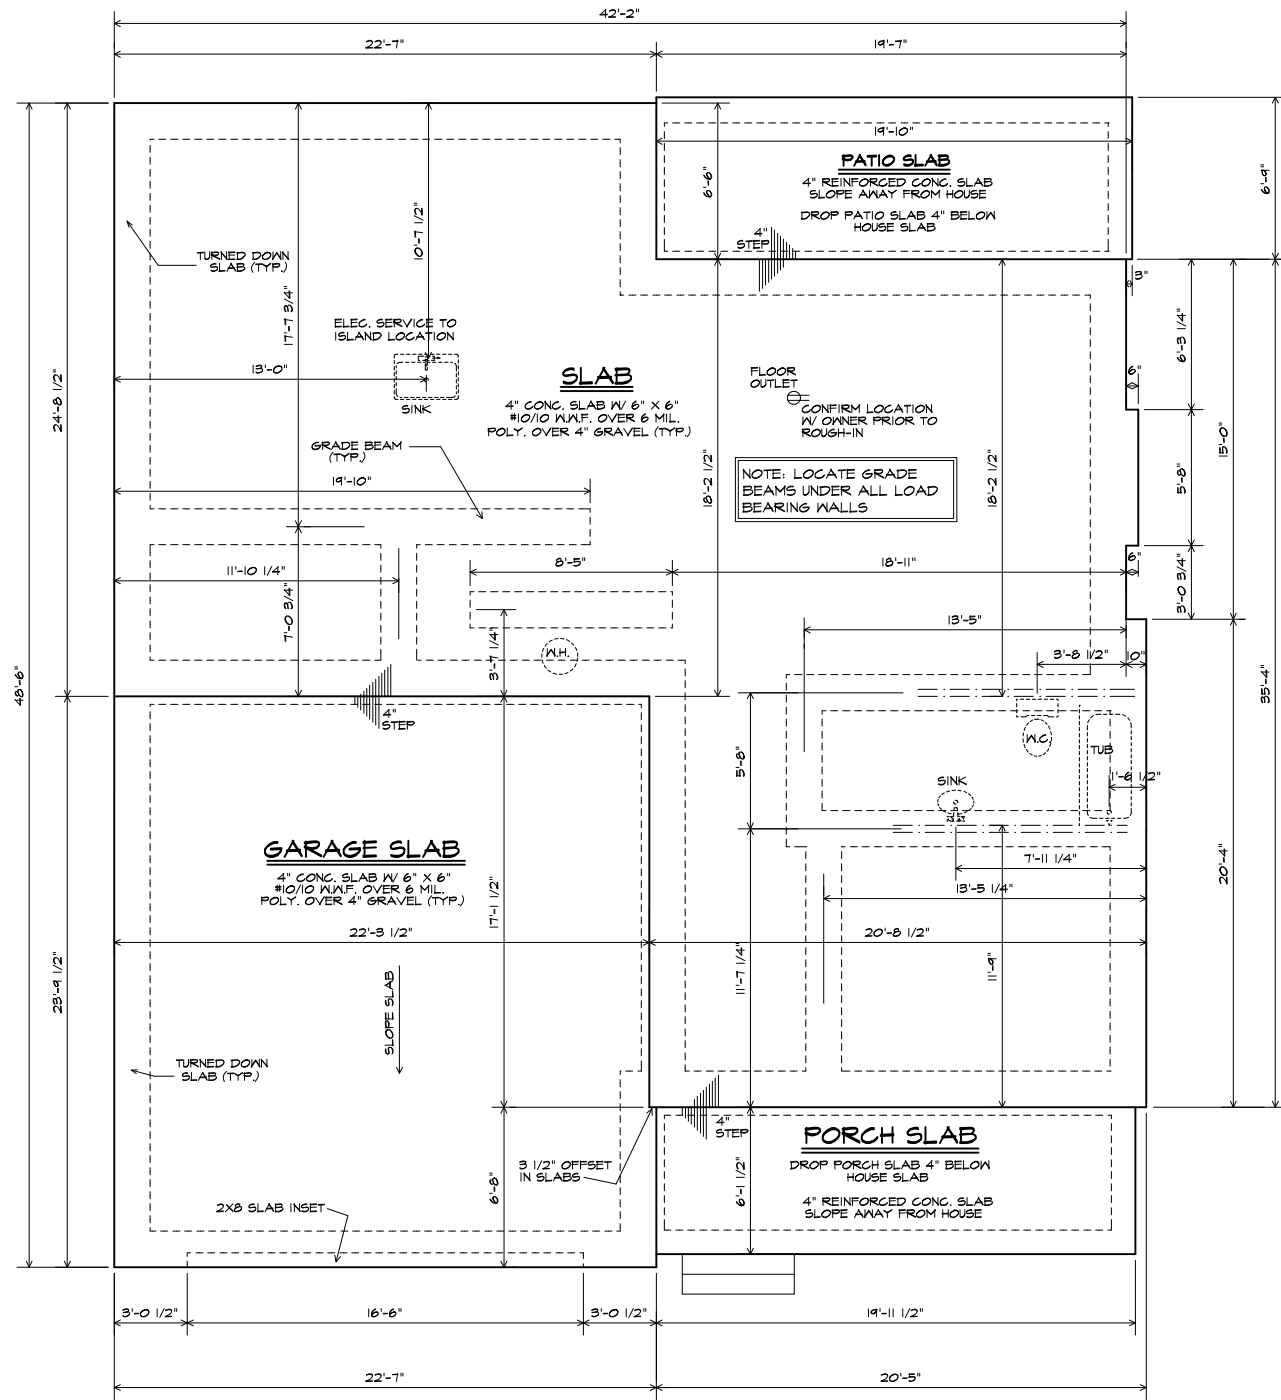


**SLAB FOUNDATION PLAN**

1/4" = 1'-0" ON 24" X 36" PAPER  
 1/8" = 1'-0" ON 11" X 17" PAPER

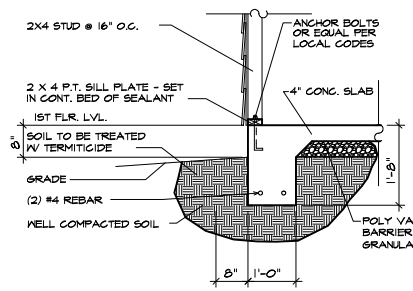


**TURN DOWN SLAB DETAIL**

1/2" = 1'-0"

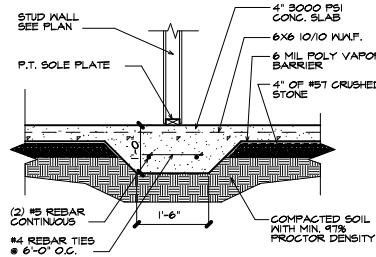


**GRADE BEAM DETAIL**

1/2" = 1'-0"

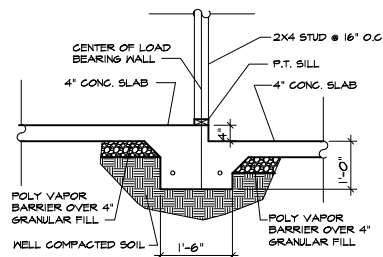

**STEPPED SLAB DETAIL**

1/2" = 1'-0"

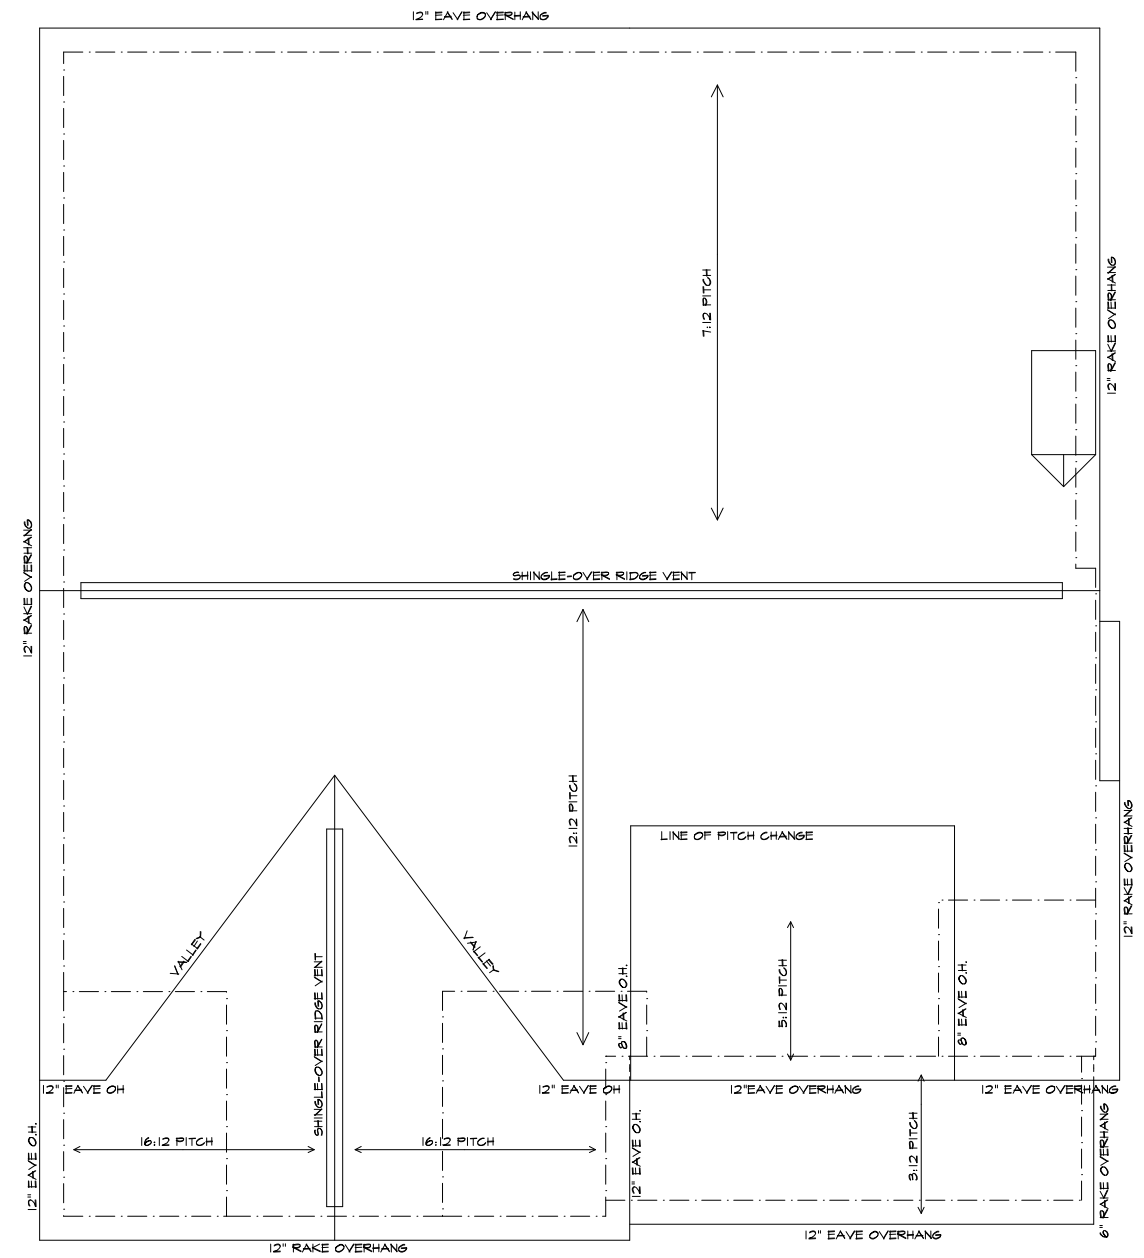

**ROOF PLAN**

1/4" = 1'-0" ON 24" X 36" PAPER  
 1/8" = 1'-0" ON 11" X 17" PAPER

SEE DETAILS ON SHEET A-6 FOR ROOF FRAMING DETAILS

SCALE: PER PLANS

PERSONAL HOME FOR THE WESOLOWSKI FAMILY

WESOLOWSKI


REVISIONS

DATE

DATE: MARCH 2022

KEYSTONE DESIGN ASSOCIATES, INC.  
 27 LAKE FOREST DRIVE, NEWNAN, GA 30265  
 PROFESSIONAL MEMBER OF THE NATIONAL COUNCIL OF BUILDING DESIGNERS  
 AMERICAN INSTITUTE OF BUILDING DESIGN




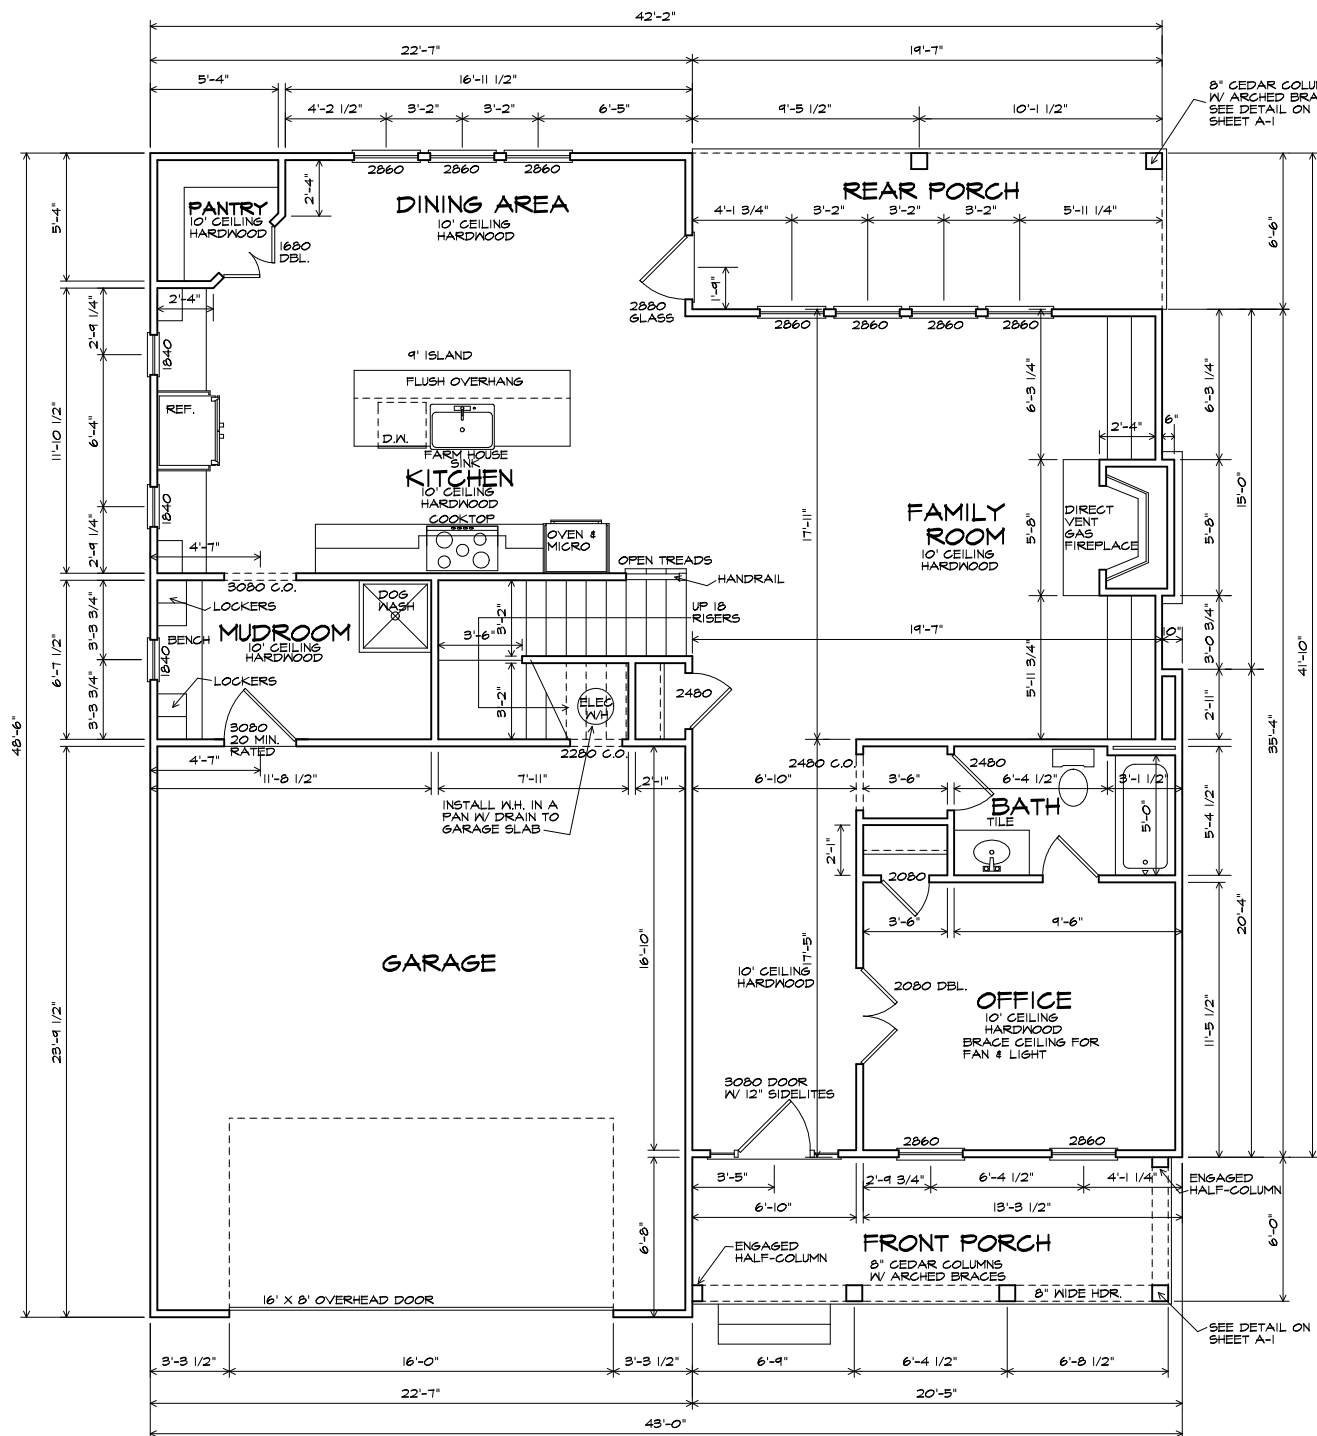

**MAIN FLOOR PLAN**

1/4" = 1'-0" ON 24" X 36" PAPER  
 1/8" = 1'-0" ON 11" X 17" PAPER

MAIN LEVEL	1274 SQUARE FEET
UPPER LEVEL	1375 SQUARE FEET
TOTAL HEATED	2649 SQUARE FEET
UNFIN. BONUS	317 SQUARE FEET
GARAGE	532 SQUARE FEET

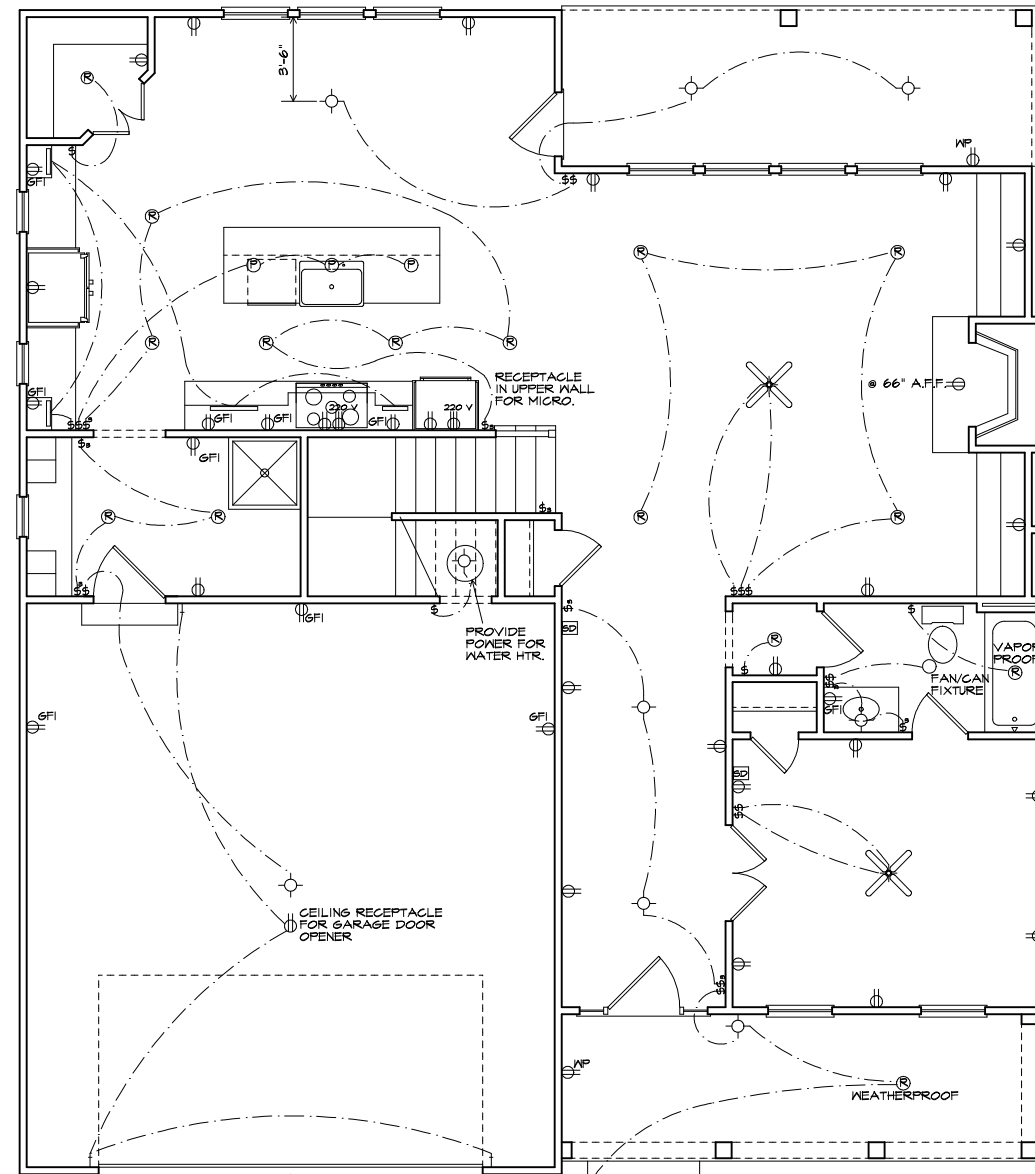

**MAIN FLOOR ELECTRICAL PLAN**

1/4" = 1'-0" ON 24" X 36" PAPER  
 1/8" = 1'-0" ON 11" X 17" PAPER

- LEGEND**
- DUPLEX RECEPTACLE
  - CEILING FAN W/ LIGHT
  - GFI RECEPTACLE
  - WALL MOUNTED FIXTURE
  - WATER PROOF RECEPTACLE
  - CEILING FIXTURE
  - BATH FAN
  - SINGLE POLE SWITCH
  - BATH FAN WITH LIGHT
  - 3 WAY SWITCH
  - CAN LIGHT
  - SMOKE DETECTOR

SCALE: PER PLANS

PERSONAL HOME FOR  
 THE WESOLOWSKI FAMILY

0 MIDDLE STREET  
 SENOIA, GEORGIA

WESOLOWSKI

MAIN LEVEL PLAN &  
 MAIN LEVEL ELECTRICAL

**REVISIONS**


NO.	DATE

DRAWN BY: R.C.  
 DATE: MARCH 2002

**KEYSTONE DESIGN ASSOCIATES, INC.**  
 27 LAKE FOREST DRIVE, NEWNAN, GA 30265


PROFESSIONAL MEMBER OF THE NATIONAL COUNCIL  
 OF BUILDING DESIGNER CERTIFICATION  
 AMERICAN INSTITUTE OF BUILDING DESIGN



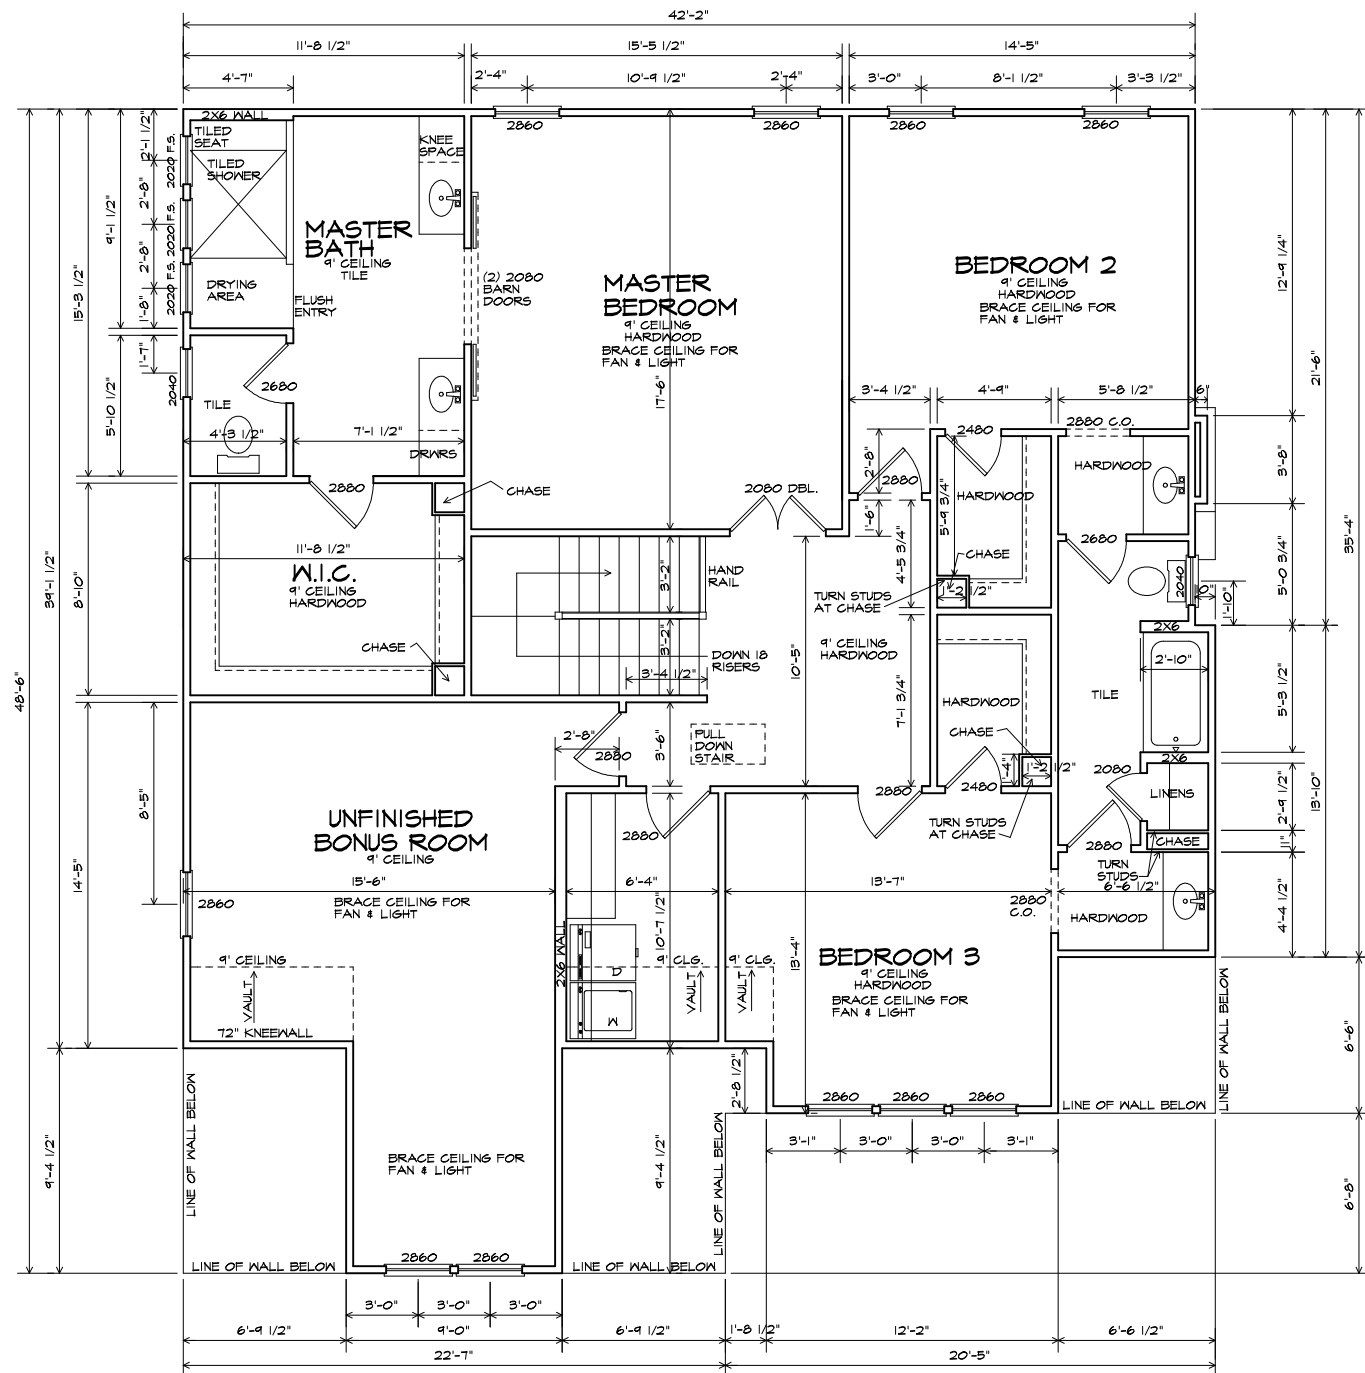


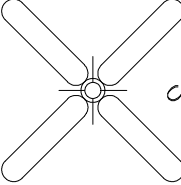




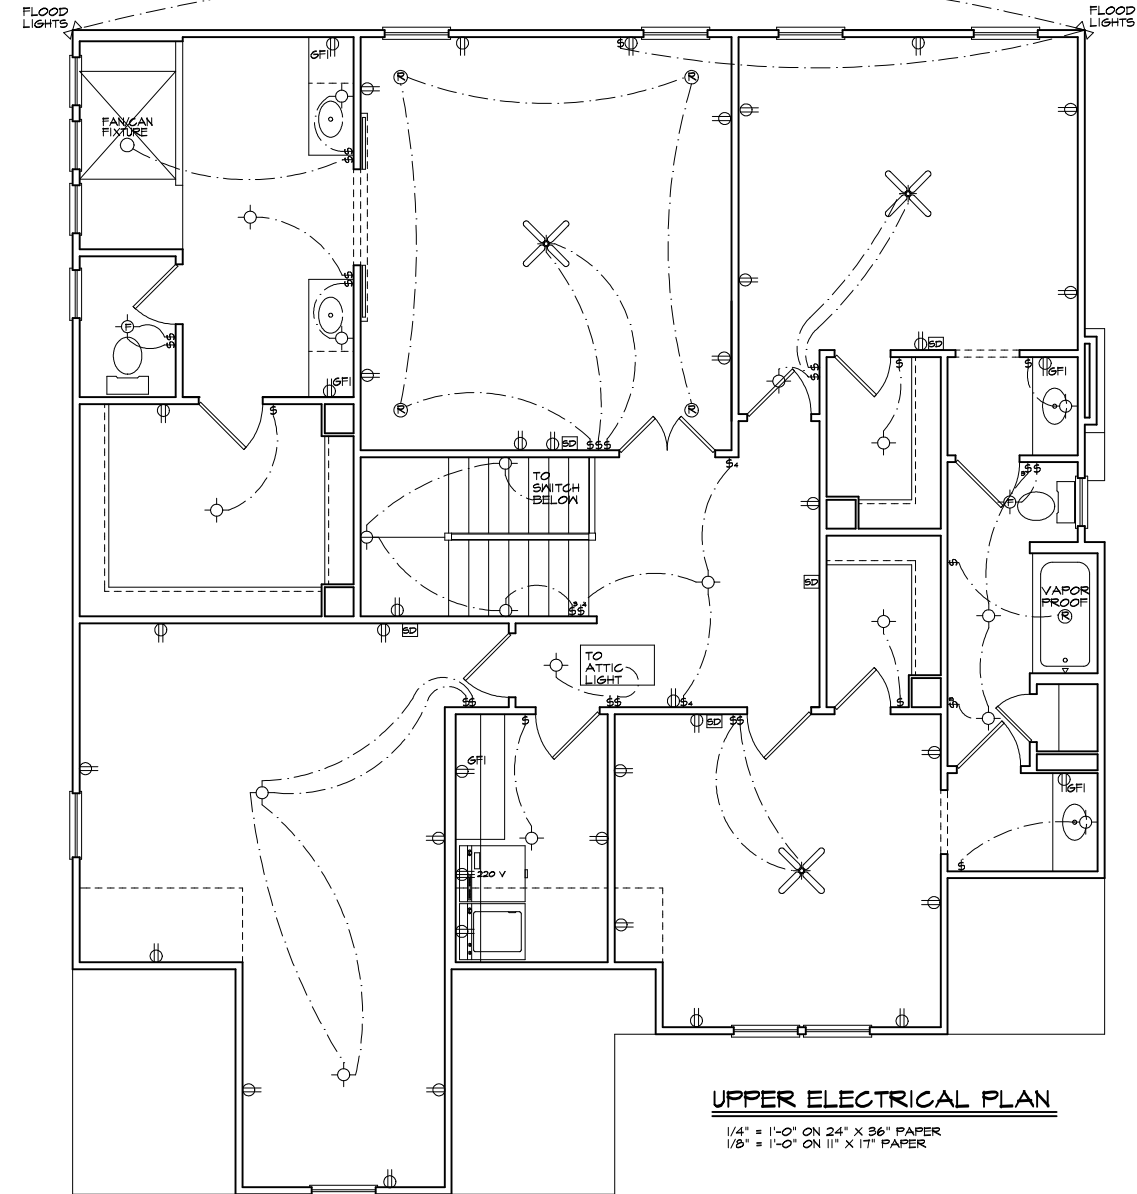




**UPPER FLOOR PLAN**

1/4" = 1'-0" ON 24" X 36" PAPER  
 1/8" = 1'-0" ON 11" X 17" PAPER



**UPPER ELECTRICAL PLAN**

1/4" = 1'-0" ON 24" X 36" PAPER  
 1/8" = 1'-0" ON 11" X 17" PAPER

- LEGEND**
- 
 DUPLEX RECEPTACLE
  - 
 CEILING FAN W/ LIGHT
  - 
 WALL MOUNTED FIXTURE
  - 
 GFI RECEPTACLE
  - 
 CEILING FIXTURE
  - 
 SMOKE DETECTOR
  - 
 BATH FAN
  - 
 SINGLE POLE SWITCH
  - 
 BATH FAN WITH LIGHT
  - 
 3 WAY SWITCH
  - 
 CAN LIGHT

SCALE: PER PLANS

PERSONAL HOME FOR  
 THE WESOLOWSKI FAMILY

0 MIDDLE STREET  
 SENOIA, GEORGIA

WESOLOWSKI

UPPER LEVEL PLAN  
 & UPPER ELECTRICAL

REVISIONS	
NO.	DATE

DRAWN BY: R.C.  
 DATE: MARCH 2022

**KEYSTONE DESIGN ASSOCIATES, INC.**  
 27 LAKE FOREST DRIVE, NEWNAN, GA 30265

PROFESSIONAL MEMBER OF THE NATIONAL COUNCIL  
 OF BUILDING DESIGNERS  
 AMERICAN INSTITUTE OF BUILDING DESIGN

